

- legenda**
- ⊞ area out of scope
 - focusing
 - vertical focusing
 - ⊞ ceiling lighting fixtures not allowed in this area
 - digital tools

project
sgh waterside shops fl n°5219
n°101858
naples, florida

code
vineyork1403-25

architect's references

view
lighting layout

file name
vineyork1403-25-v103.dwg

scale/size
1:50@A2

n° drawing
01/01



date
2026 04 24

previous review
V102_1_20260423

UpO ref
UpOdue/er

non working drawing

all the drawings are ownership of Viabizzuno s.r.l. - every use or divulgation of them is allowed only after the authorization of Viabizzuno s.r.l.

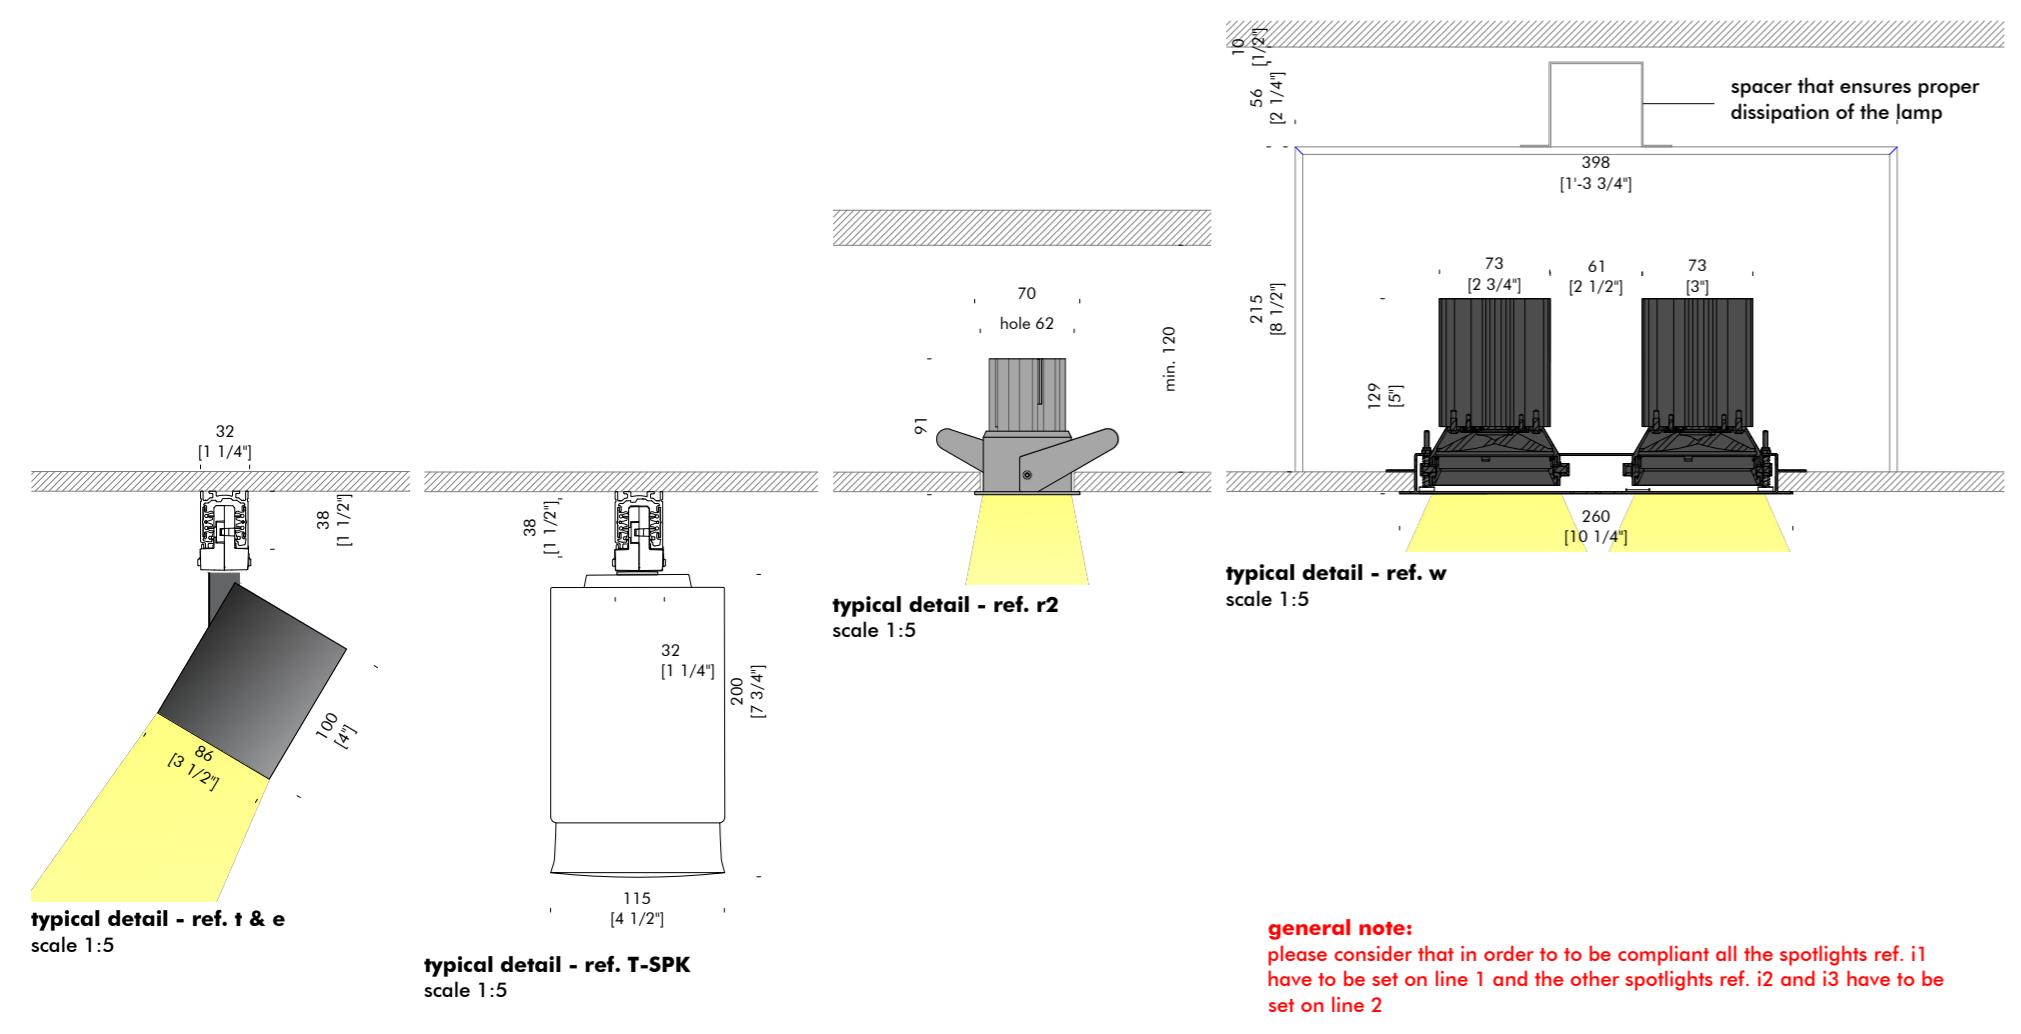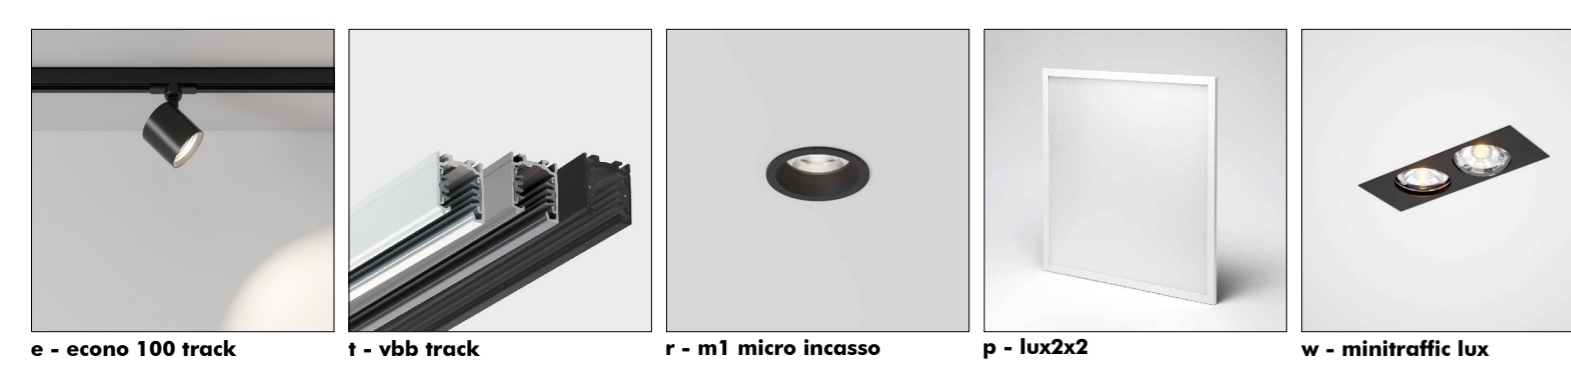


general note:
please consider that in order to be compliant all the spotlights ref. i1 have to be set on line 1 and the other spotlights ref. i2 and i3 have to be set on line 2

*n1: the quantity of the lux2x2 lighting fixtures must be respected as per drawing on the other hand, their disposition is indicative and must be adapted taking in consideration the real measurements of the grid's executive design. as far as the executive project is concerned, it must follow the guidelines.

please note that an inspection hatch must be always provided for lux2x2 panel, in order to allow rear access to the panel.

please note that the lux2x2 panel must be set to temperature colour of 3000K

APPROVED
DESIGN - AON
04/27/2026

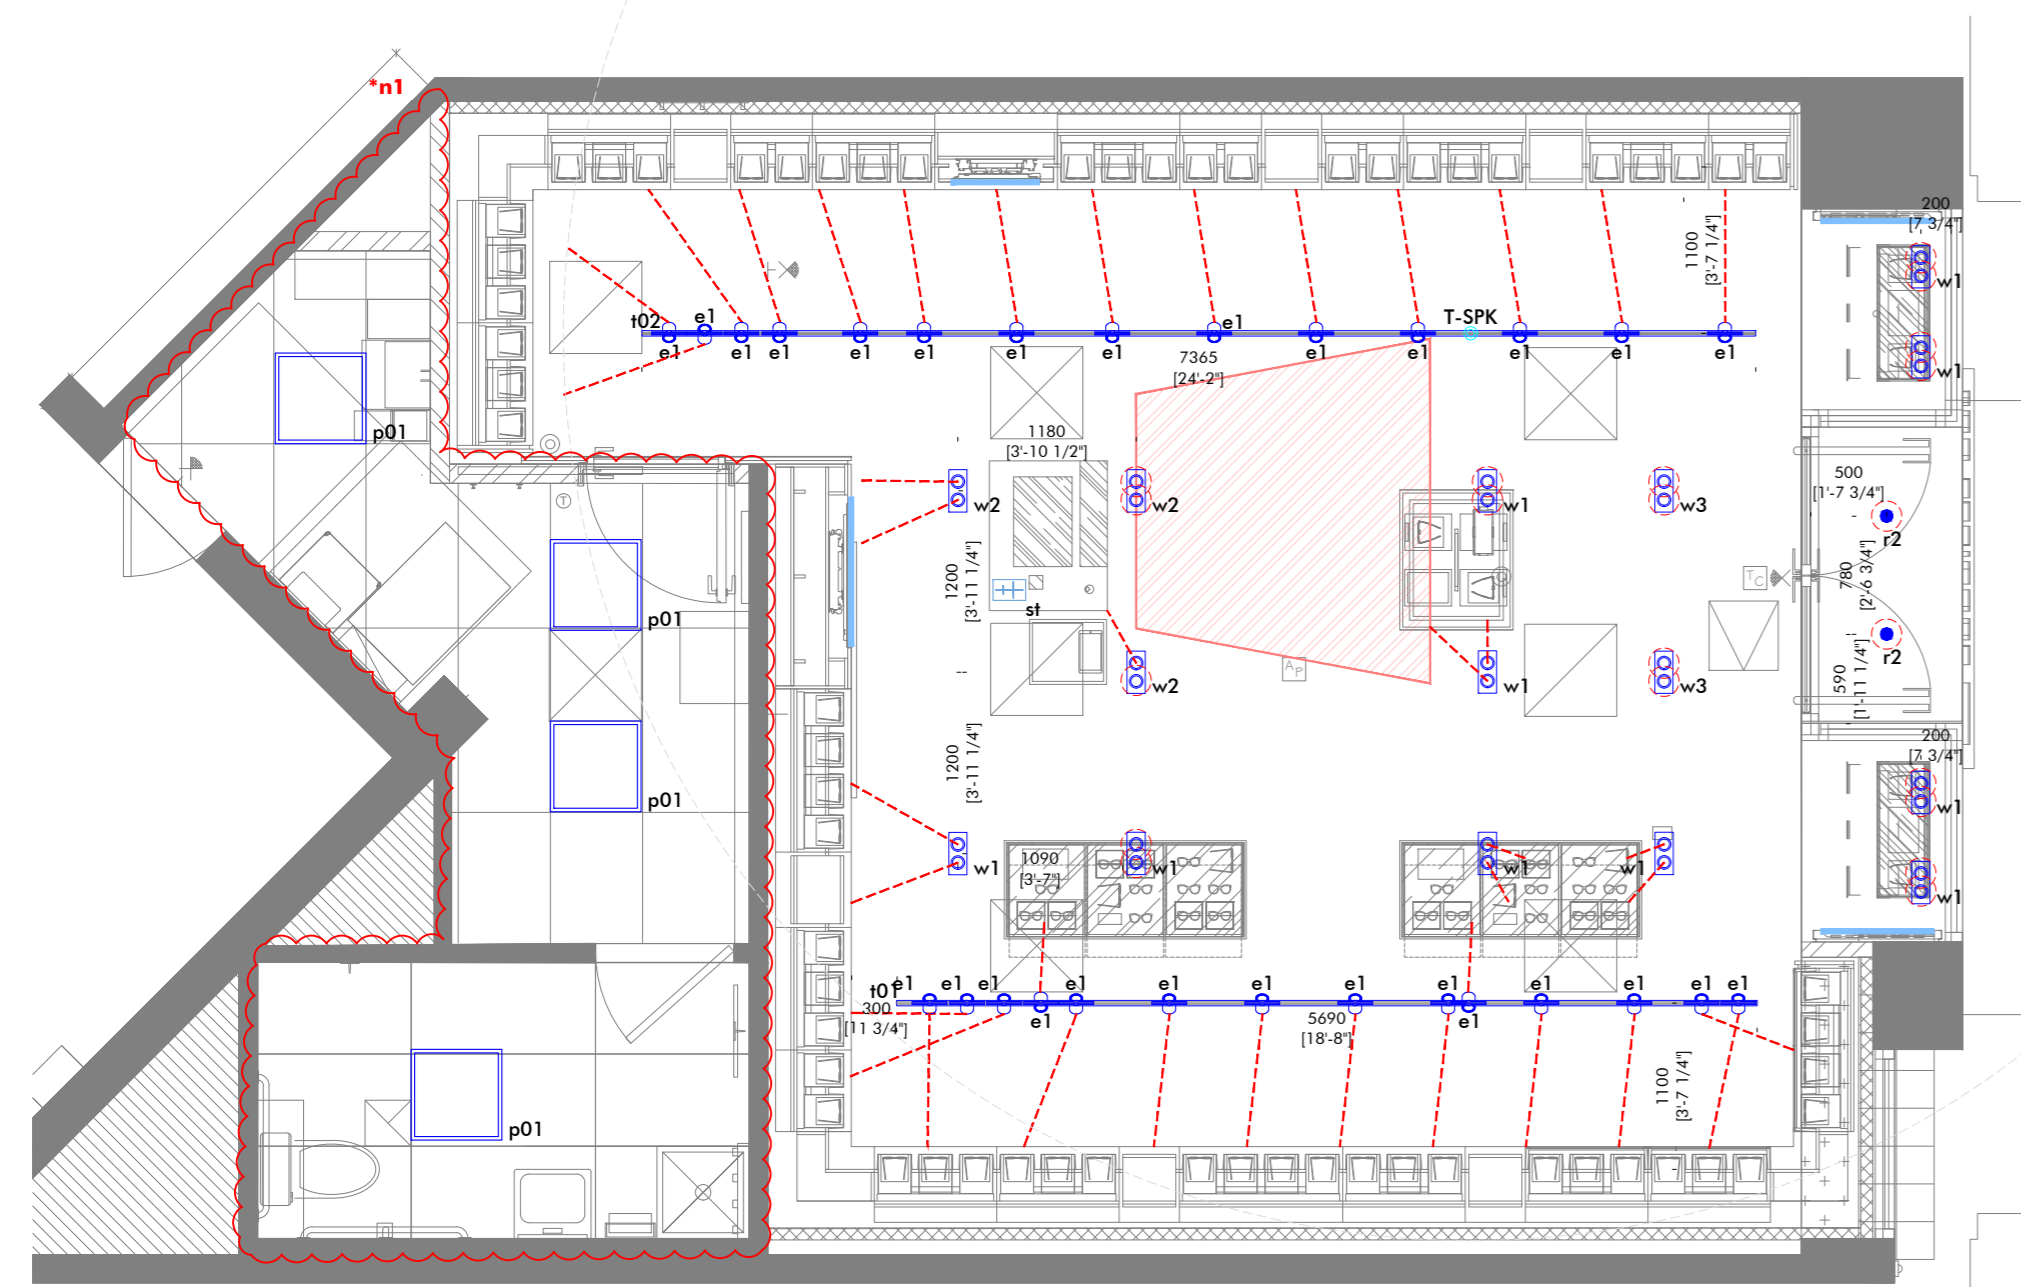

lighting layout
scale 1:50

shopwindow					
m ²	m height	W	lm	W/m ²	lm/m ²
3.5	3.35	148.8	19500	42.51	5571.43

shopwindow					
sqf	feet height	W	lm	W/sqf	lm/sqf
38	11'	148.8	19500	3.92	513.16

retail area					
m ²	m height	W	lm	W/m ²	lm/m ²
56	3.5	983.2	101700	17.56	1816.07

retail area					
sqf	feet height	W	lm	W/sqf	lm/sqf
602	11'-6"	983.2	101700	1.63	168.94

ref	description	qty	W	tot W
T-SPK	spot011b - spottune track speaker , black 18W 50-15000Hz RF-Band 1,8-1,9Ghz Ø115mm H200mm, 100-240V 50/60Hz	1	18.0	18.0
e1	LUX.001.04.U.L - econo 100 track black 15° led 3000K Ra98 R9 98 20.5W 2100lm 120V, not dimmable power supply on board	28	20.5	574.0
p01	170603.ul - lux2x2 white 120° led 3000K 3800lm 600x600mm 120V, dimmable driver 0-10V, power supply included	4	40.0	160.0
r2	Vb6.608.09.30.n.u - m1 micro recessed fixed ø70 nero55 16.8w led 3000k 1791lm 36° Ra98 sdm2 IES - TM30 Rf93 Rg99 500mA, remote dimmable power supply	2	16.8	33.6
st	spots1fb - spottune stream transmitter for audio distribution system, black, 215x168x45mm, 100 - 220V 50/60Hz	1	0.0	0.0
i01	track VbB 3-120V 16A black, surface mounted total length 18'-8" (5690mm)	1	0.0	0.0
i02	track VbB 3-120V 16A black, surface mounted total length 24'-2" (7365mm)	1	0.0	0.0
w1	LUX.002.01.U.L - minitrafic lux black 2x15° led 3000K Ra98 R9 98 2x18,6W 2x1950lm 120V, dimmable driver 0-10V power supply included, frame included	10	37.2	372.0
w2	LUX.002.02.U.L - minitrafic lux black 2x24° led 3000K Ra98 R9 98 2x18,6W 2x1950lm 120V, dimmable driver 0-10V power supply included, frame included	3	37.2	111.6
w3	LUX.002.03.U.L - minitrafic lux black 2x31° led 3000K Ra98 R9 98 2x18,6W 2x1950lm 120V, dimmable driver 0-10V power supply included, frame included	2	37.2	74.4
		53	1343.6	